


This drawing is copyright and MUST NOT be reproduced or used for any other purpose without written permission from E.ON UK PLC. Copyright may result in legal action. The contractor is responsible for checking dimensions and any discrepancies to be worked with E.ON UK PLC before proceeding. Figures dimensions only to be worked to unless stated. IF IN DOUBT ALWAYS ASK.

NOTES

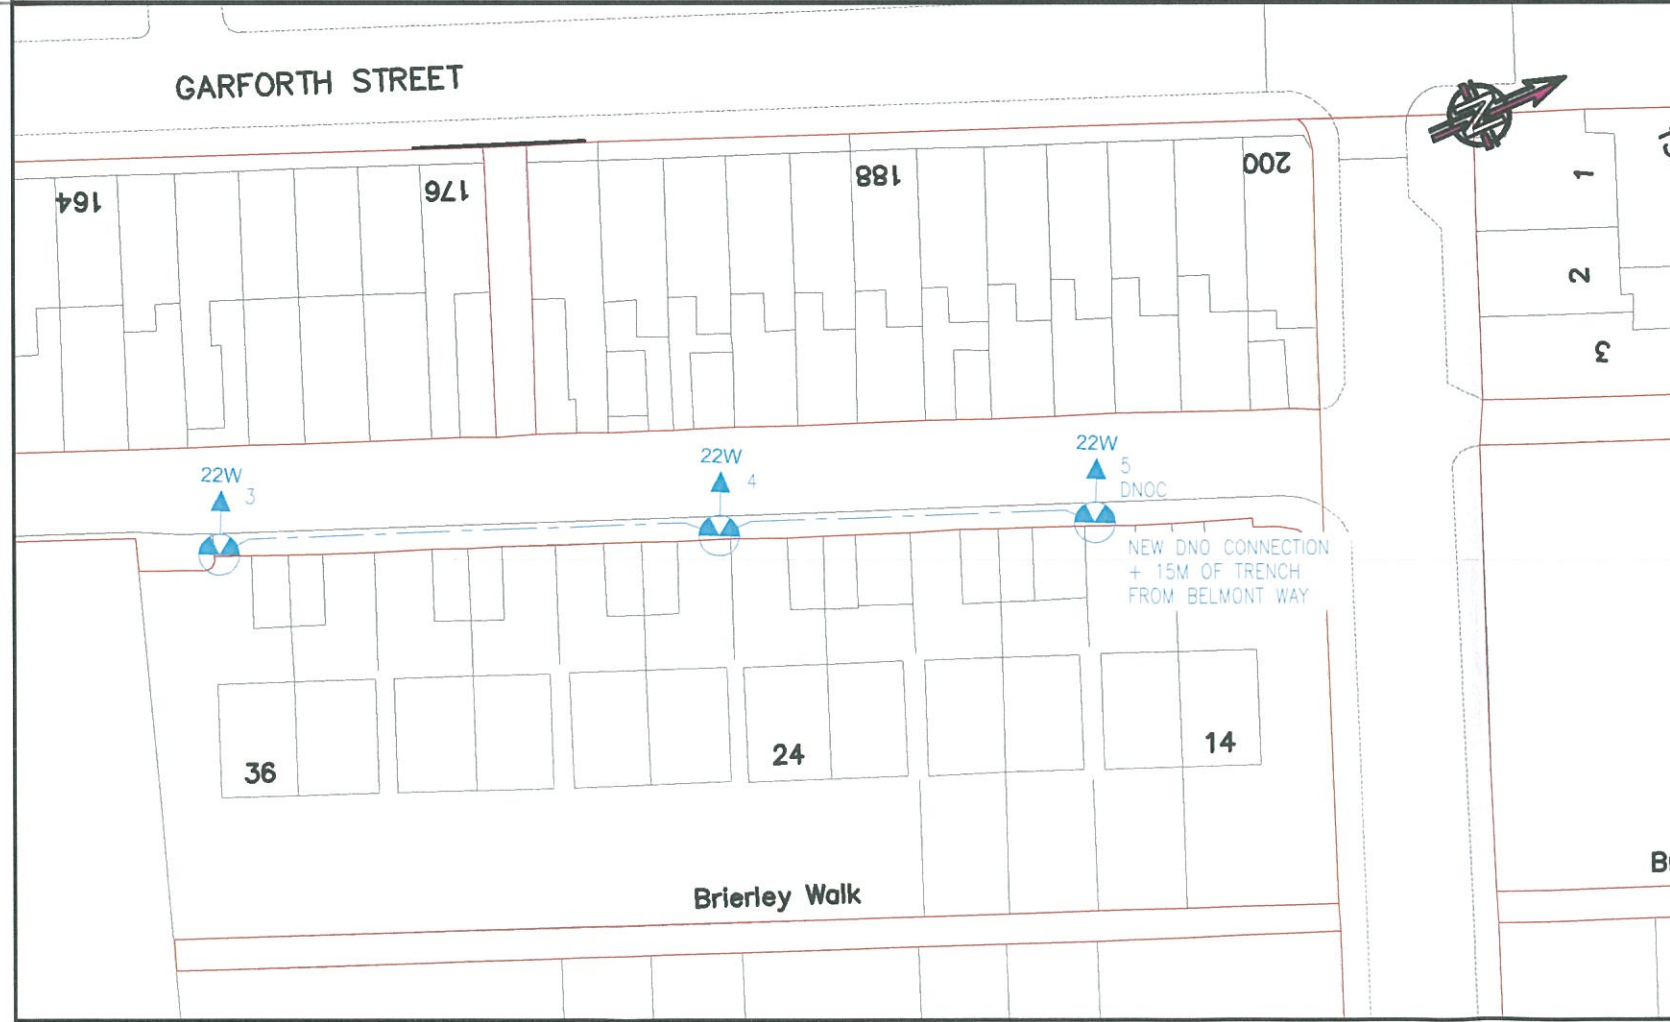

**KEY**

- Proposed 6m Nominal height steel column with planted root having a post top mounted Urbis Sapphire FG luminaire unit incorporating 16 LED 500mA complete with Harvard Engineering LeafNut remote monitoring equipment.
- Proposed 6mm sq street lighting power supply cable laid in Orange High Density Polyethylene ducting as per Eon Standard detail for footway Construction.
- Distribution Network Operator Connection required.

REV	DATE	DETAILS	BY

Client	Ockham Council		
Project	Garforth Street, Lighting Design Ockham Works		
Title	Proposed Lighting layout		
Dwg No.	1011 DWG 001	Revision	A
Scales	1:500	Sheet	A3
Drawn	P.J.B	Checked	P.J.B
		Approved	P.L
		Date	14.01.2012